


KEYPLAN
0 15000
P-002 6269-P-002a

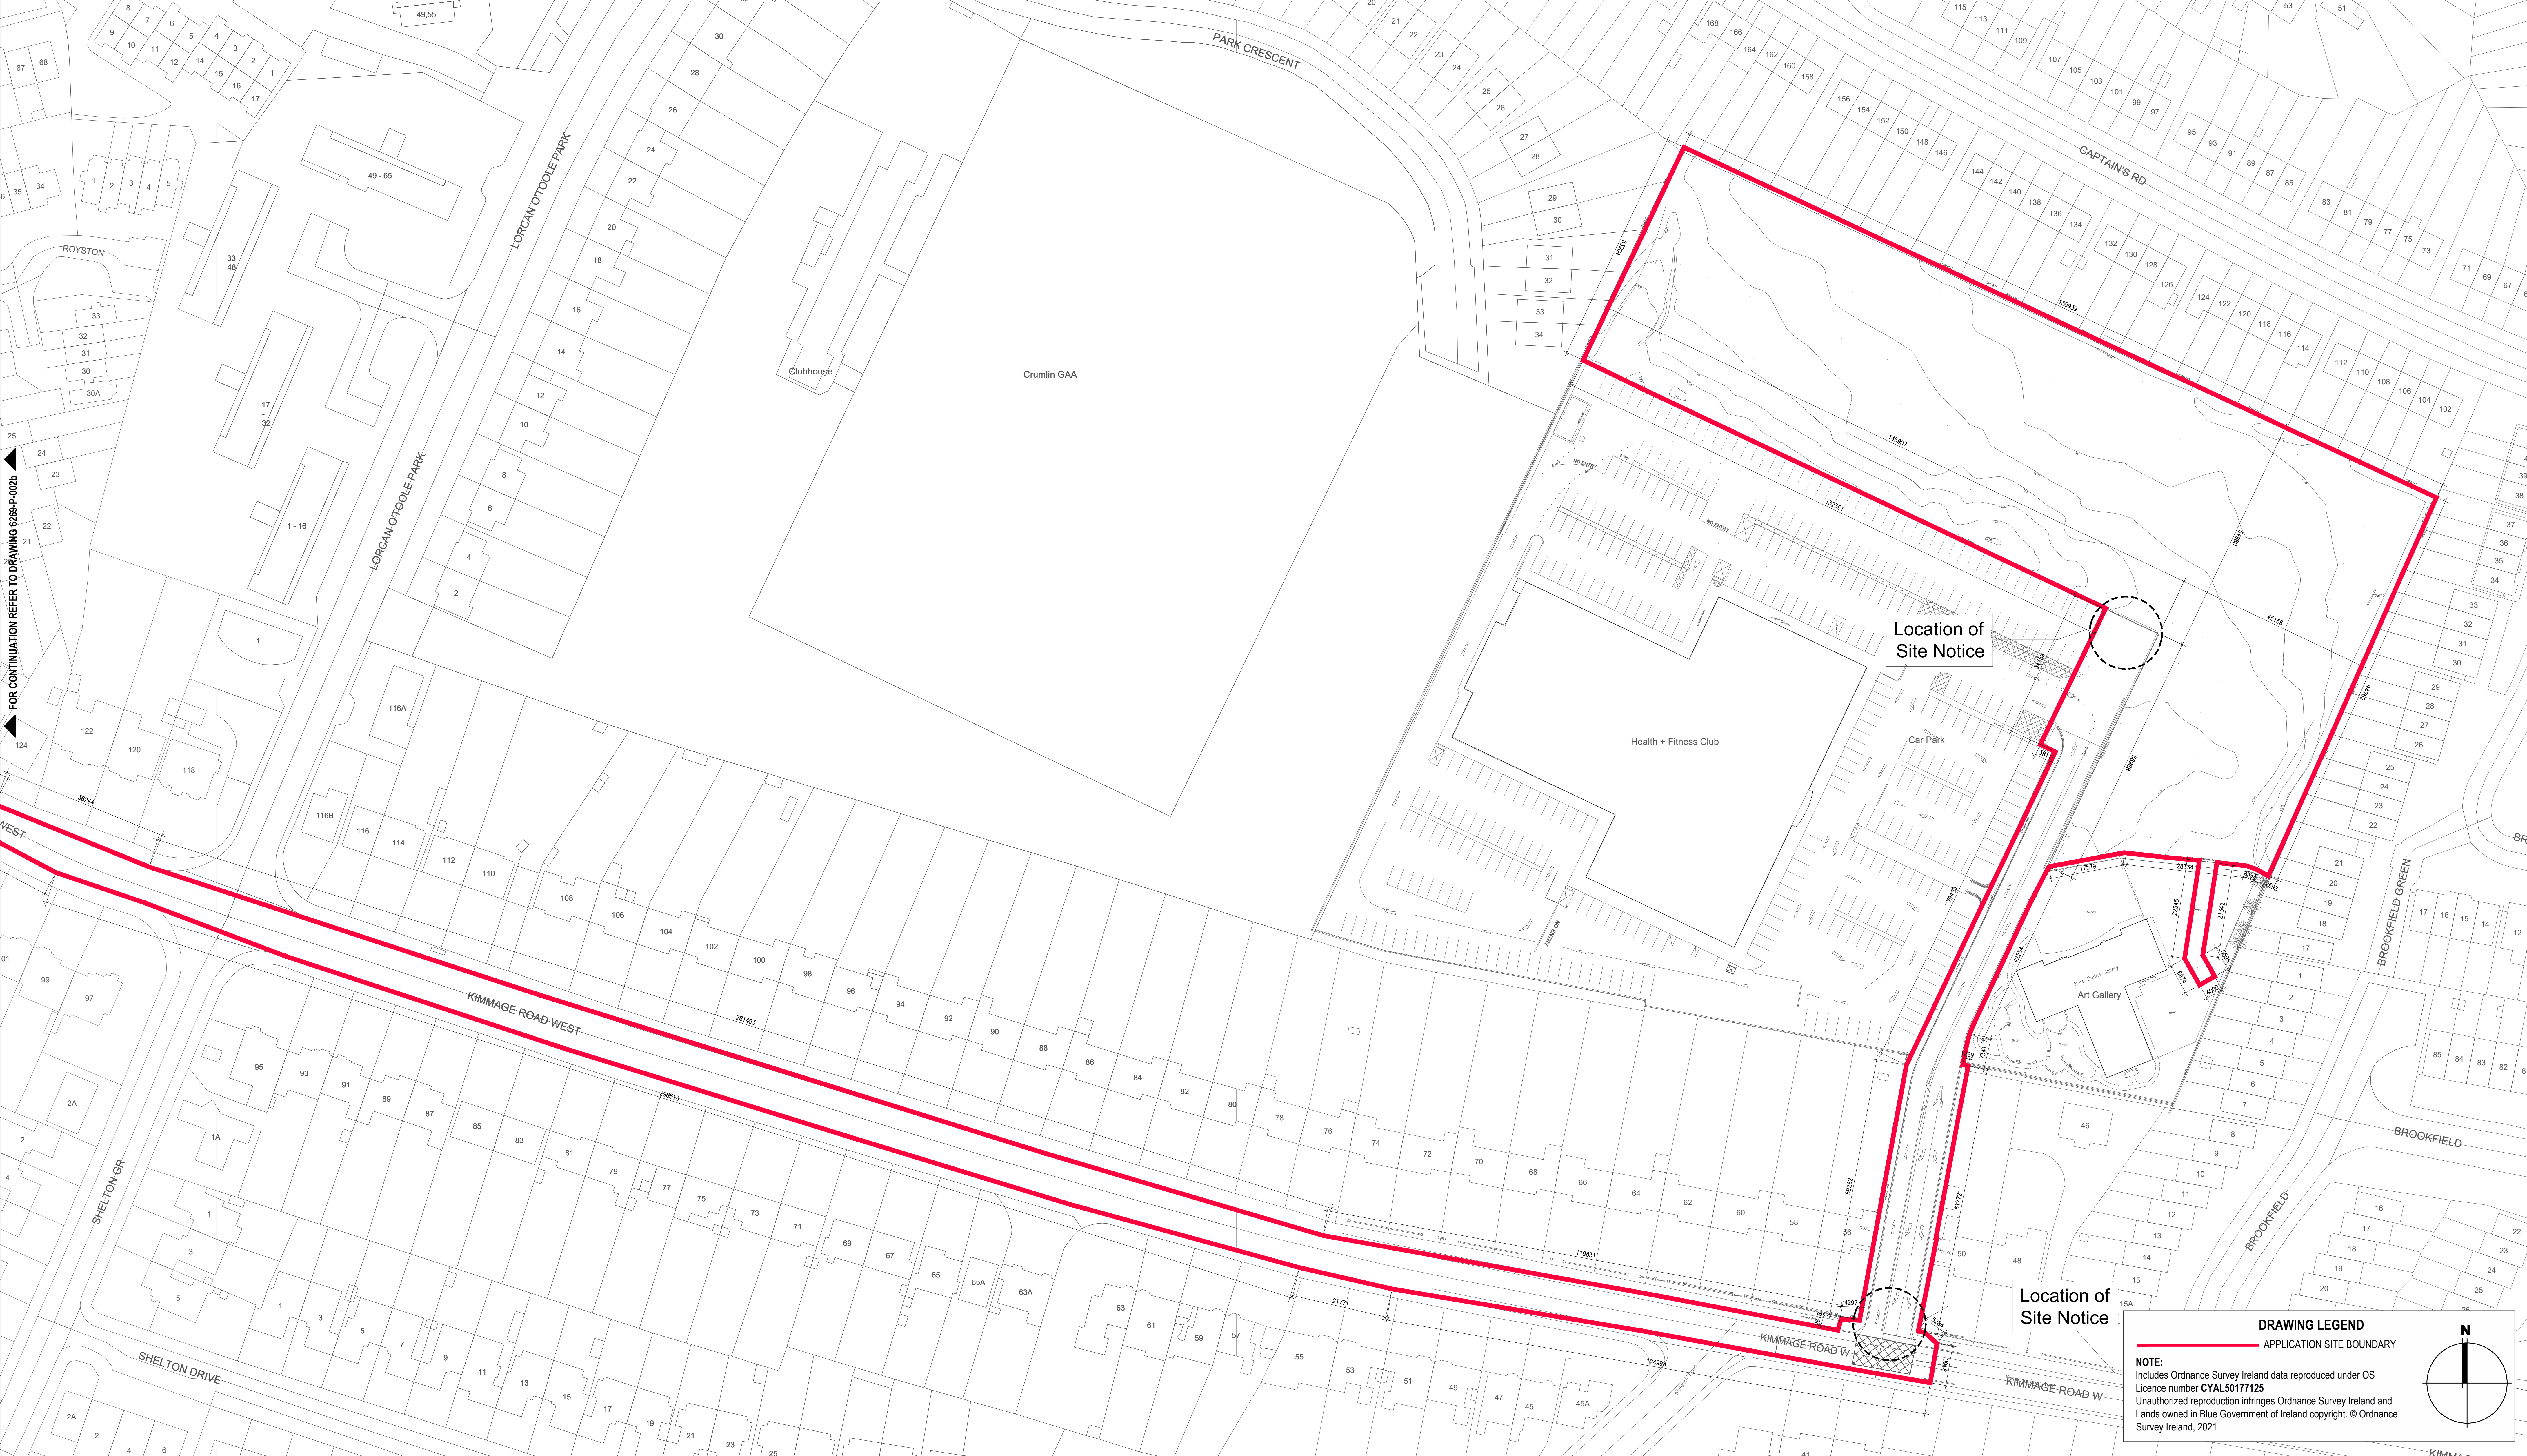

Location of Site Notice

Location of Site Notice

DRAWING LEGEND
 APPLICATION SITE BOUNDARY

NOTE:
 Includes Ordnance Survey Ireland data reproduced under OS Licence number CYAL50177125
 Unauthorized reproduction infringes Ordnance Survey Ireland and Lands owned in Blue Government of Ireland copyright. © Ordnance Survey Ireland, 2021

Notes:
 1. Copyright Reserved
 2. This is a proposed site plan only. Do not scale drawing.
 3. The contractor is responsible for ensuring all details and dimensions on site and shall refer all discrepancies to the Architect.
 4. Where appropriate, for details of civil, structural, or mechanical and electrical details, see Engineers drawings.
 5. Proprietary items shall be based on and accordance with manufacturers instructions.
 6. Sites of geological interest shall be checked with the developer.
 7. The contractor shall be responsible for the coordination of structure, fixtures and services.

Issue Status	Progress
Planning Application	Finalised
Fire Cert	Finalised
Disability Cert	Finalised
Typing	Finalised
Construction	Finalised
As Built	Finalised
Information Only	Finalised

No.	Date	Revision
01	24/09/21	First Issue [Drawn]
02	08/10/21	Issued for general review
03	12/12/21	2D architectural drawing pack
04	04/02/22	Issued for general review
05	09/02/22	Issued for general review
06	11/03/22	Issued for Planning

Project: **Carlisle Site, Kimmage Residential Development**
 Drawing Title: Existing Site Layout Plan - Sheet 12
 Drawing No: 6269-P-002a
 Scale: 1:500@A0 Rev: 06 Drawn: BKD Date: Oct 21

bkd architects
 BURKE-SHEEHAN DOYLE