



1 Site Elevations - Block2 East Elevation
1 : 200

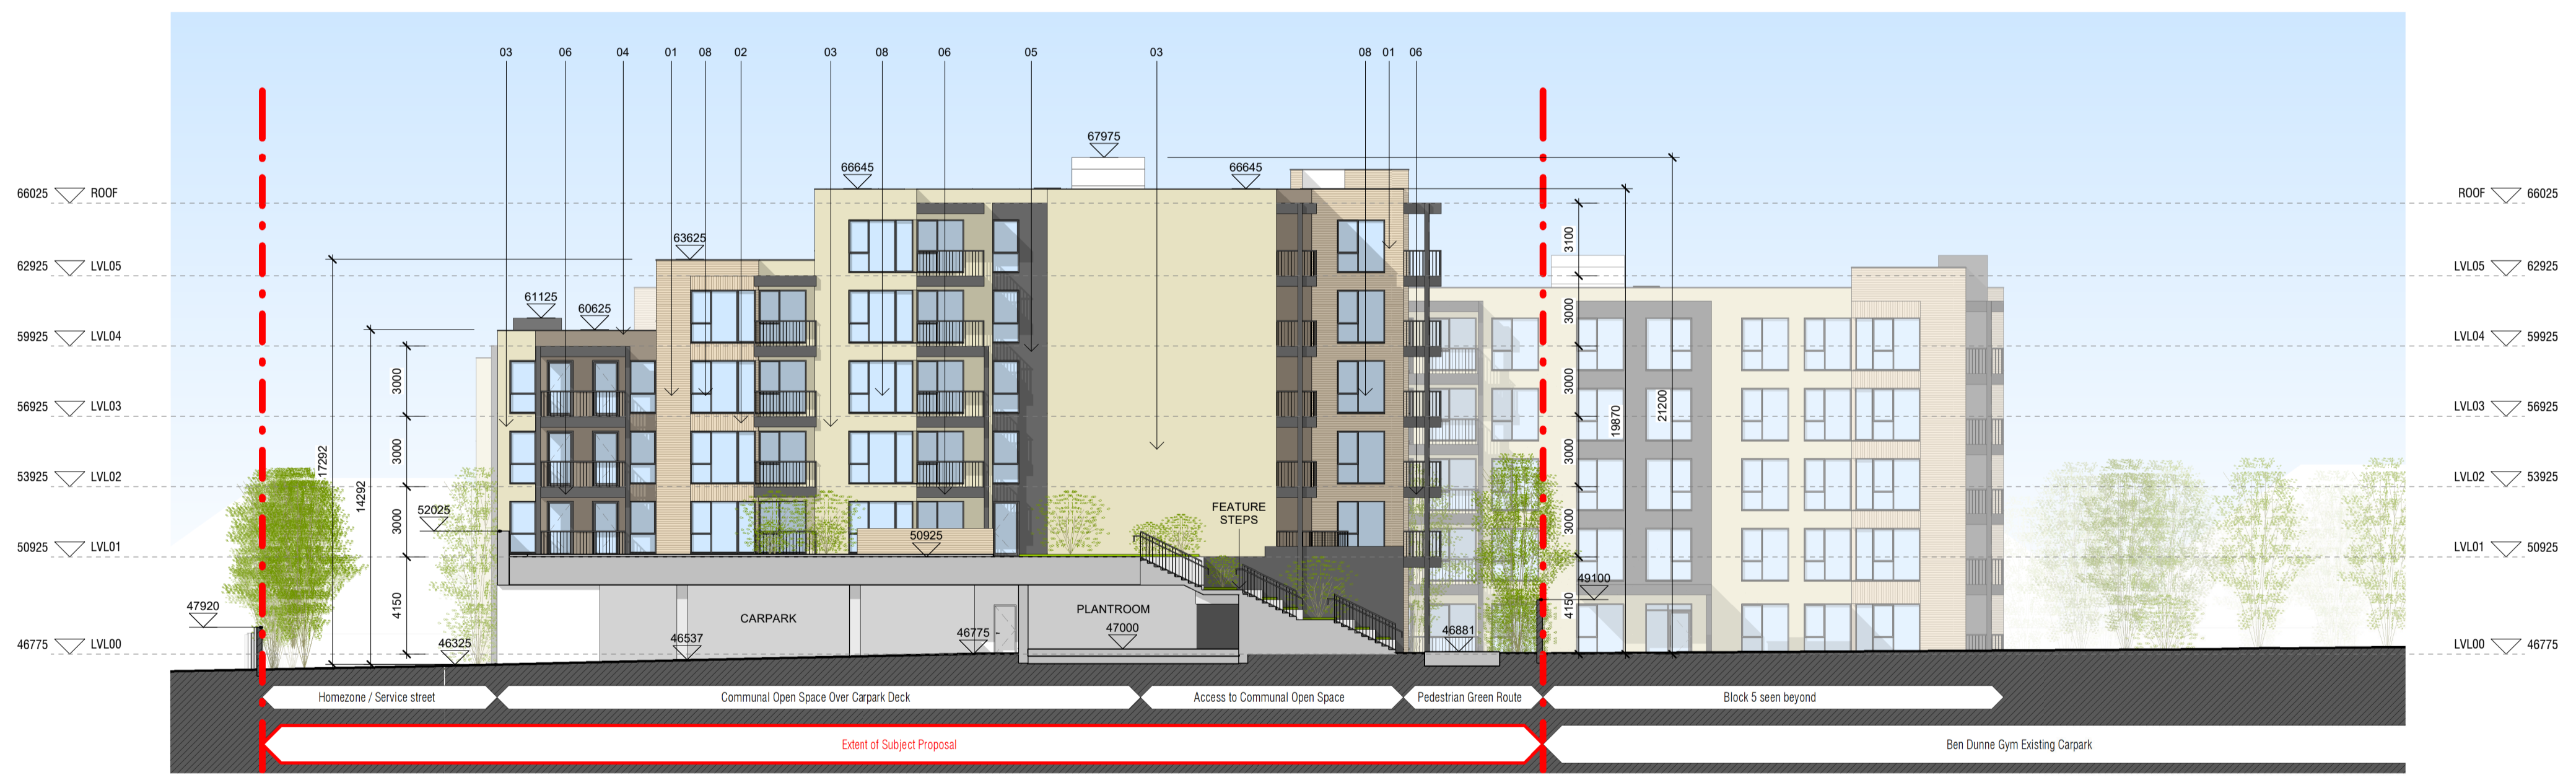

2 Site Elevations - Block3 West Elevation
1 : 200

MATERIAL CODE LEGEND

- 01 - BUFF BRICK - STANDARD BOND - LIGHT SAND TONE
- 02 - BUFF BRICK - FEATURE BOND - LIGHT SAND TONE
- 03 - SELF COLOURED RENDER - CREAM / OFF-WHITE TONE
- 04 - SELF COLOURED RENDER - PALE BROWN / TAN TONE
- 05 - SELF COLOURED RENDER - DARK GREY / CHARCOAL TONE
- 06 - POWDERCOATED METALWORK - DARK GREY / CHARCOAL TONE
- 07 - POWDERCOATED METAL SCREENING - DARK GREY / CHARCOAL TONE
- 08 - CLEAR GLAZING WITH DARK GREY / CHARCOAL TONE FRAMING
- 09 - OPACIFIED GLAZING WITH DARK GREY / CHARCOAL TONE FRAMING TO A HEIGHT OF 1200mm ABOVE FLOOR LEVEL

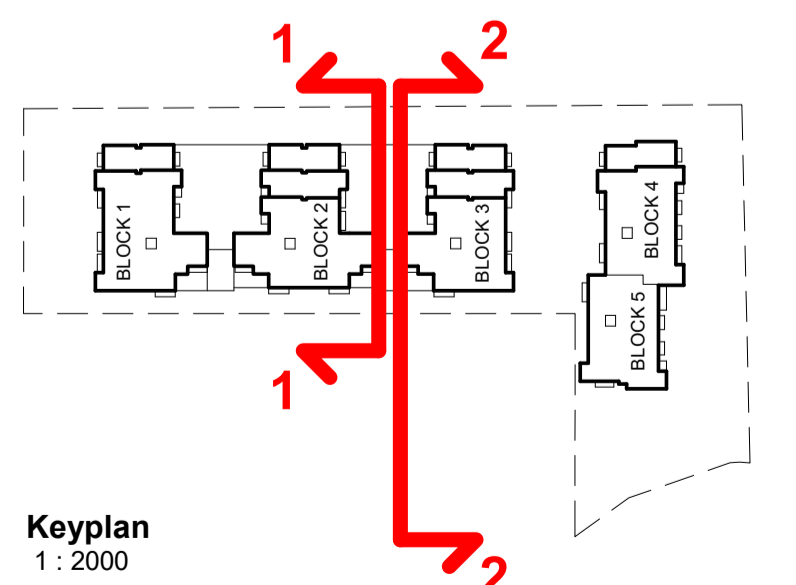

Notes	Issue Status
1. Copyright Reserved	Progress
2. Work to figured dimensions only. Do not scale drawing	Planning Application
3. The contractor is responsible for checking all levels and dimensions on site and shall refer all discrepancies to the Architect	Fire Cert
4. Where appropriate, for details of f.c. structure, or mechanical and electrical details, see Engineers drawings	Disability Cert
5. Proprietary items shall be fixed in strict accordance with manufacturers instructions.	Tender
6. Sizes of proprietary items shall be checked with manufacturer.	Construction
7. The contractor shall be responsible for the coordination of structure, finishes and services.	As Built
	Information Only

No.	Date	Revision	Issued
1	17/09/21	First issue / Draft	BKD
2	08/10/21	Issued for general review	BKD
3	12/10/21	SHD architectural drawing pack	BKD
4	04/02/22	Issued for general review	BKD
5	02/03/22	Issued for general review	BKD
6	11/03/22	Issued for Planning	BKD

Project Carlisle Site Residential Development			
52-54 Kimmage Rd West, Kimmage, Dublin 12			
Drawing Title Proposed Site Elevations - Internal Elevations - Sheet 2/3			
Drawing No 6269 - P - 153			
Scale 1:200@A1	Rev 6	Drawn BKD	Date Oct 2021

6-7 HARCOURT TERRACE, DUBLIN 2, IRELAND
 T +353-1-818 2400 F +353-1-878 7385
 architecture@bkd.ie
 www.bkd.ie

bkdarchitects
 BUNKE-KENNEDY DOYLE